


DRUM LEVEL ELECTRICAL ENCLOSURE (EE-128)

FIELD PROCESS AREA

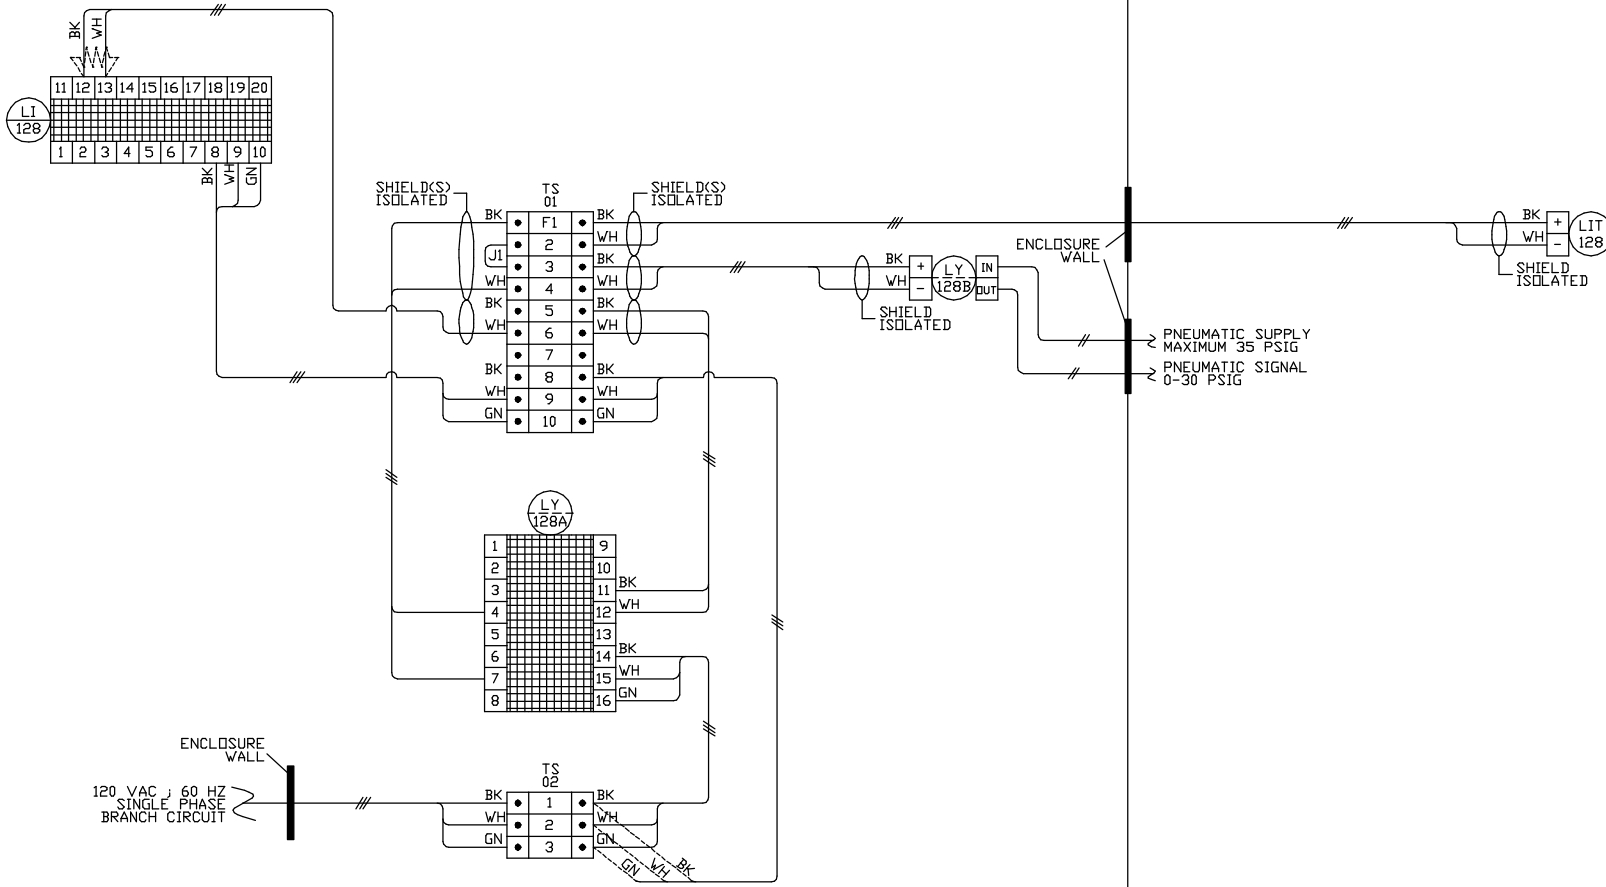

TAG No.	DESCRIPTION	MANUFACTURER	MODEL No.	CALIBRATION	SPEC. No.	INSTALL DETAIL	PURCHASE ORDER	P&ID DVG.
L1-128	DIGITAL INDICATOR	YOKOGAWA	UM330-00	-15.0 to 15.0 INCHES				
L11-128	DIFFERENTIAL PRESS. XMITTER	ROSEMOUNT	3051CD2A52A1A	0-30.0 INCHES W.C.				
LY-128A	SIGNAL CONDITIONER	YOKOGAWA	JUXTA WA1A	4-20mA IN/4-20mA OUT				
LY-128B	I/P TRANSDUCER	ROSEMOUNT	3311DMIH	0-30 PSIG				
F1	FUSE	BUSS		250V ; 1/4 AMP				
EE-128	ELECTRICAL ENCLOSURE	HOFFMAN	A-201612LP	20" X 16" X 12"				

**LEGEND:**

 250 OHM RESISTOR

**INTEGRAL CONTROL SYSTEM SERVICES, INC.**  
**ICSS**  
 1303 BACKETT AVENUE  
 Cuyahoga Falls, Ohio 44223  
 Office: 330-623-8900 Fax: 330-623-2116

THIS DRAWING IS THE PROPERTY OF INTEGRAL CONTROL SYSTEM SERVICES, INC. AND IS NOT TO BE REPRODUCED, COPIED, OR TRANSMITTED IN ANY FORM OR BY ANY MEANS, ELECTRONIC OR MECHANICAL, INCLUDING PHOTOCOPYING, RECORDING, OR BY ANY INFORMATION STORAGE AND RETRIEVAL SYSTEM. NO USE OF THIS DRAWING OR ITS CONTENTS IS TO BE MADE WITHOUT THE WRITTEN PERMISSION OF INTEGRAL CONTROL SYSTEM SERVICES, INC.

TITLE		CUSTOMER	
BOILER 1 DRUM LEVEL		INSTRUMENT LOOP DIAGRAM NO. 128	
DATE	APP'D. BY:	DATE	APP'D. BY:
	LA		MM
DWG. No.	052598-1		